
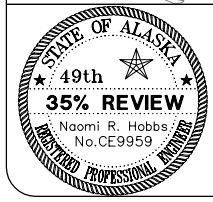
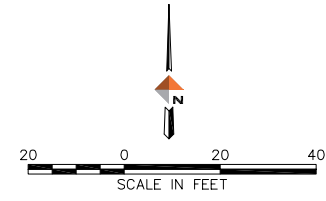


Q:\24\71014-01\65CAD\MC-CS-BA-71014.dwg 2018-11-14 07:40:18

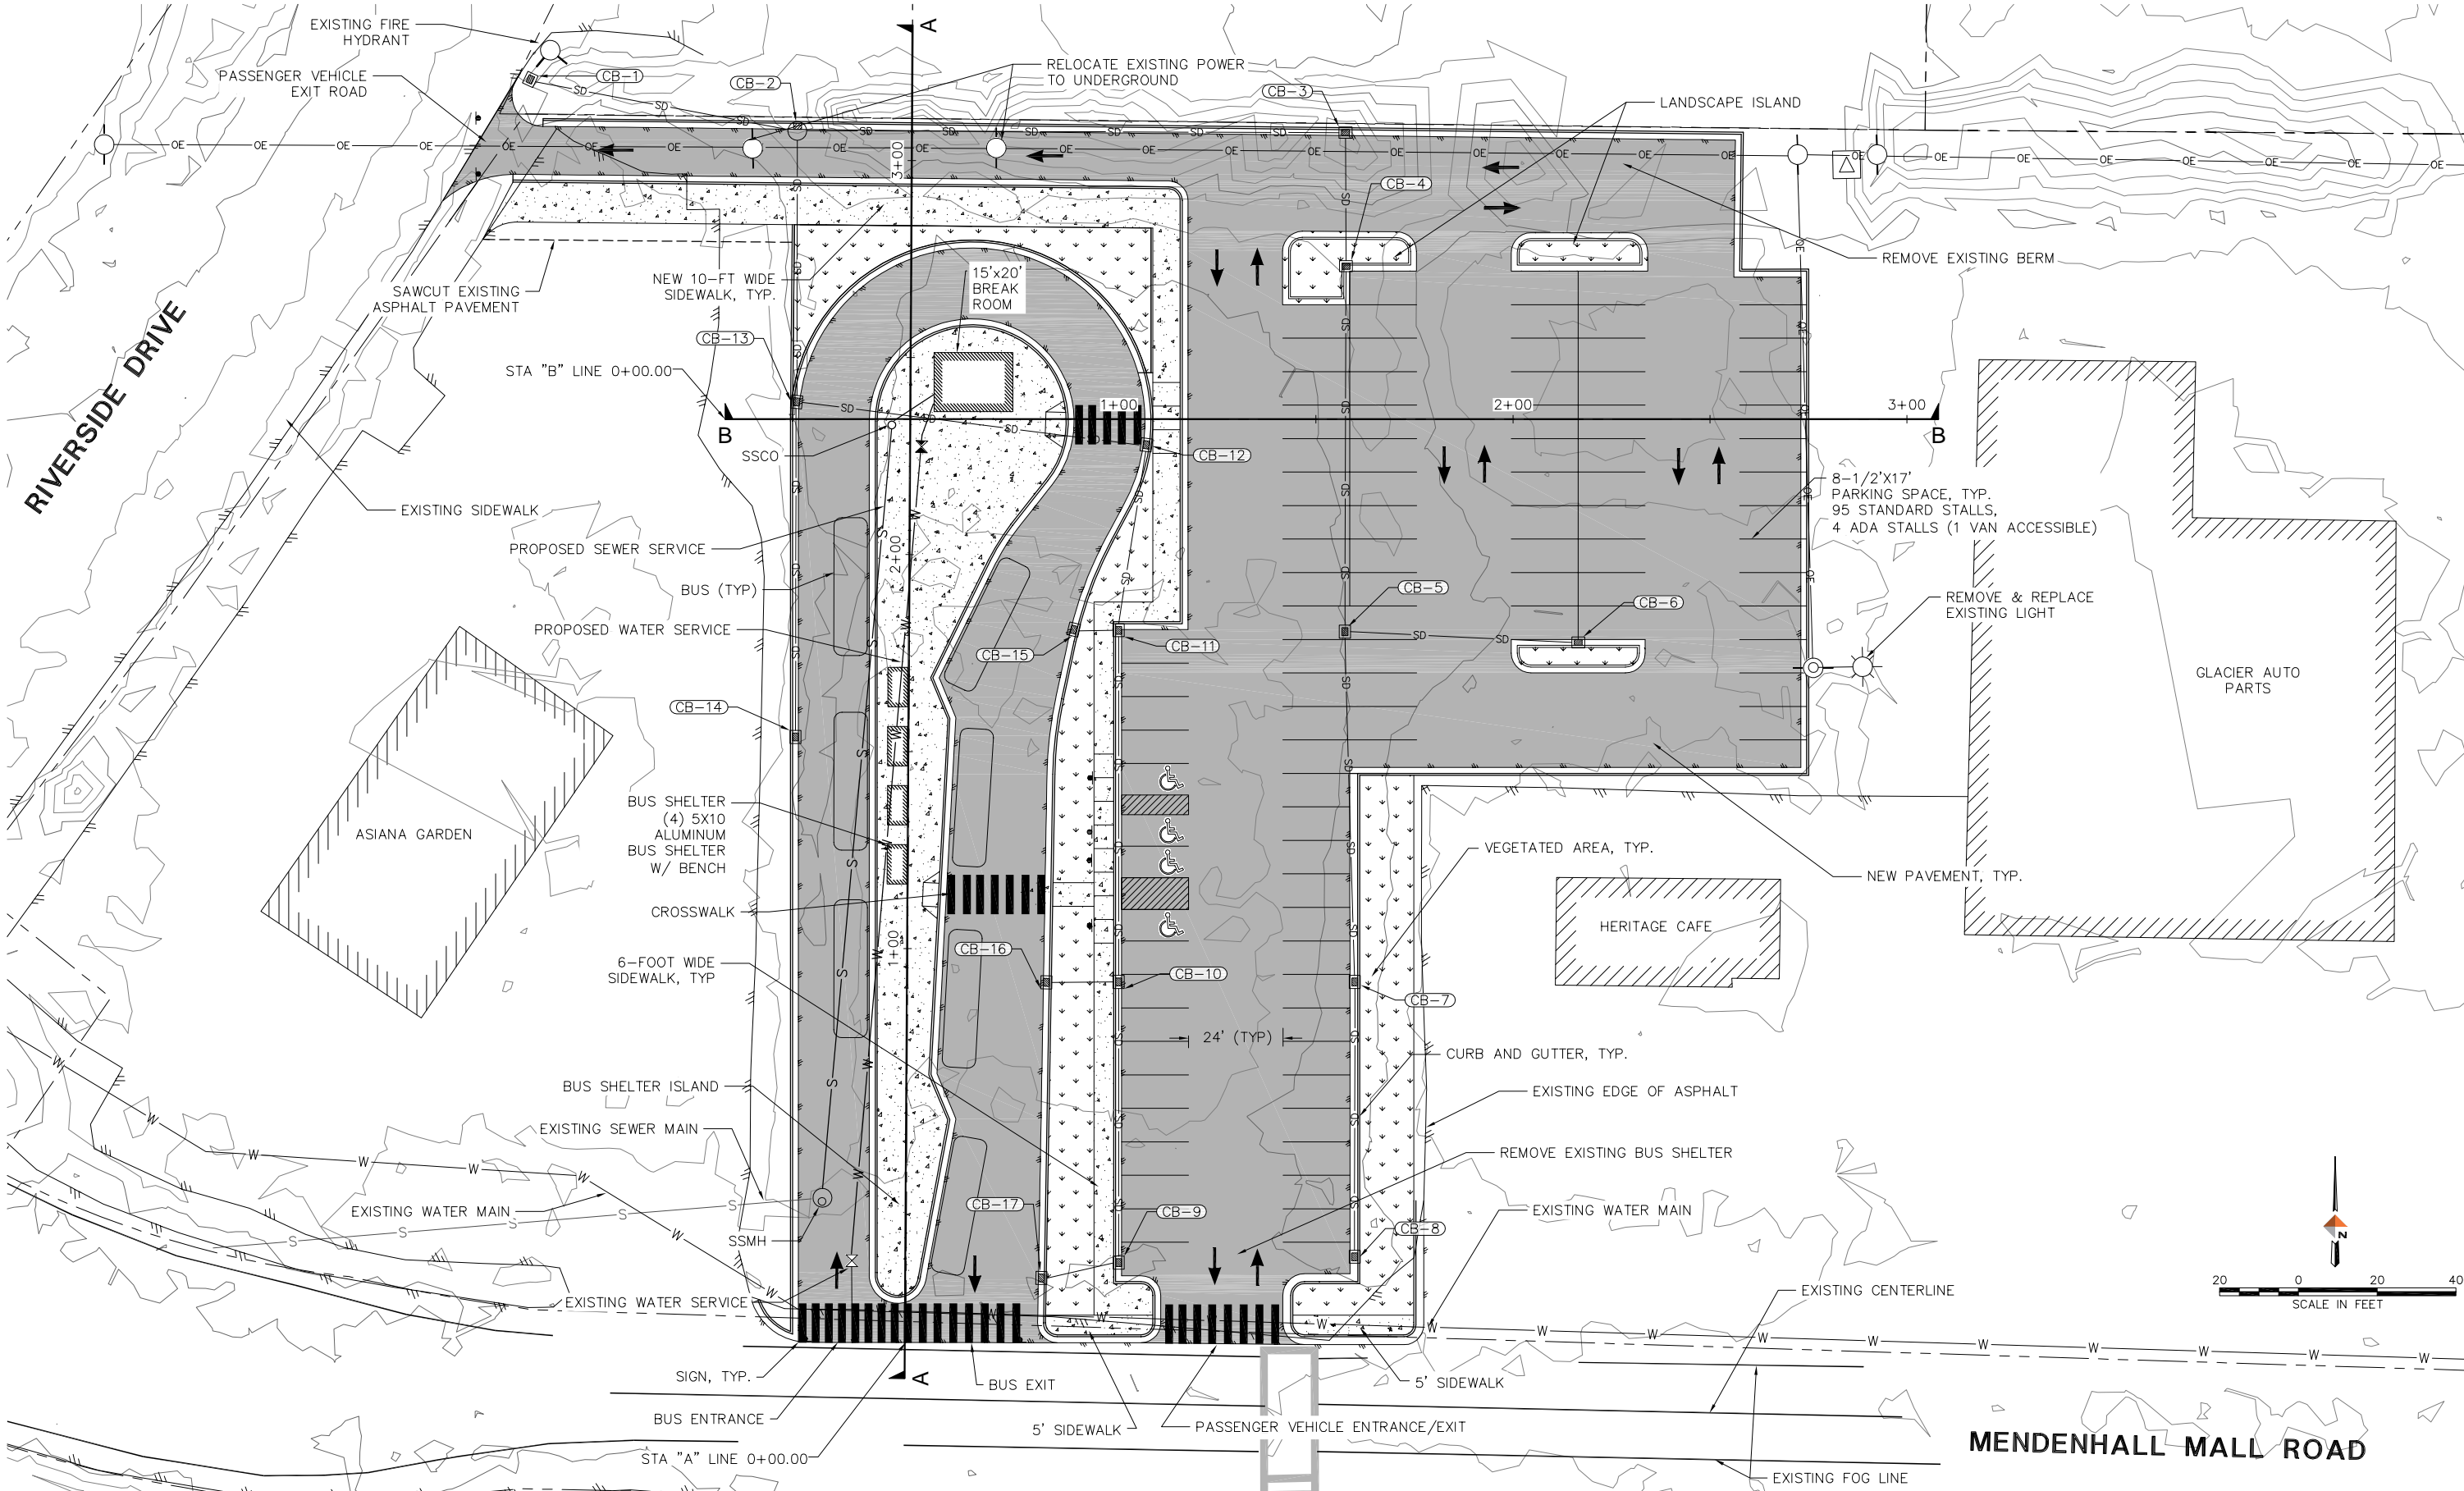

DOWL
 Consulting Engineers • Land Surveyors • Construction Administration

PLANS DEVELOPED BY:
 DOWL
 5368 COMMERCIAL BOULEVARD
 JUNEAU, ALASKA 99801
 907-780-3533
 AECL848

JOB No. J71014.01 DRAWN BY: STAFF DESIGNED BY: STAFF CHECKED BY: STAFF DATE: NOV. 2018

CITY/BOROUGH OF JUNEAU
 ALASKA'S CAPITAL CITY

DEPARTMENT OF ENGINEERING

**CAPITAL TRANSIT
 VALLEY TRANSIT CENTER**

SITE PLAN

SHEET NO.
1
 of
2